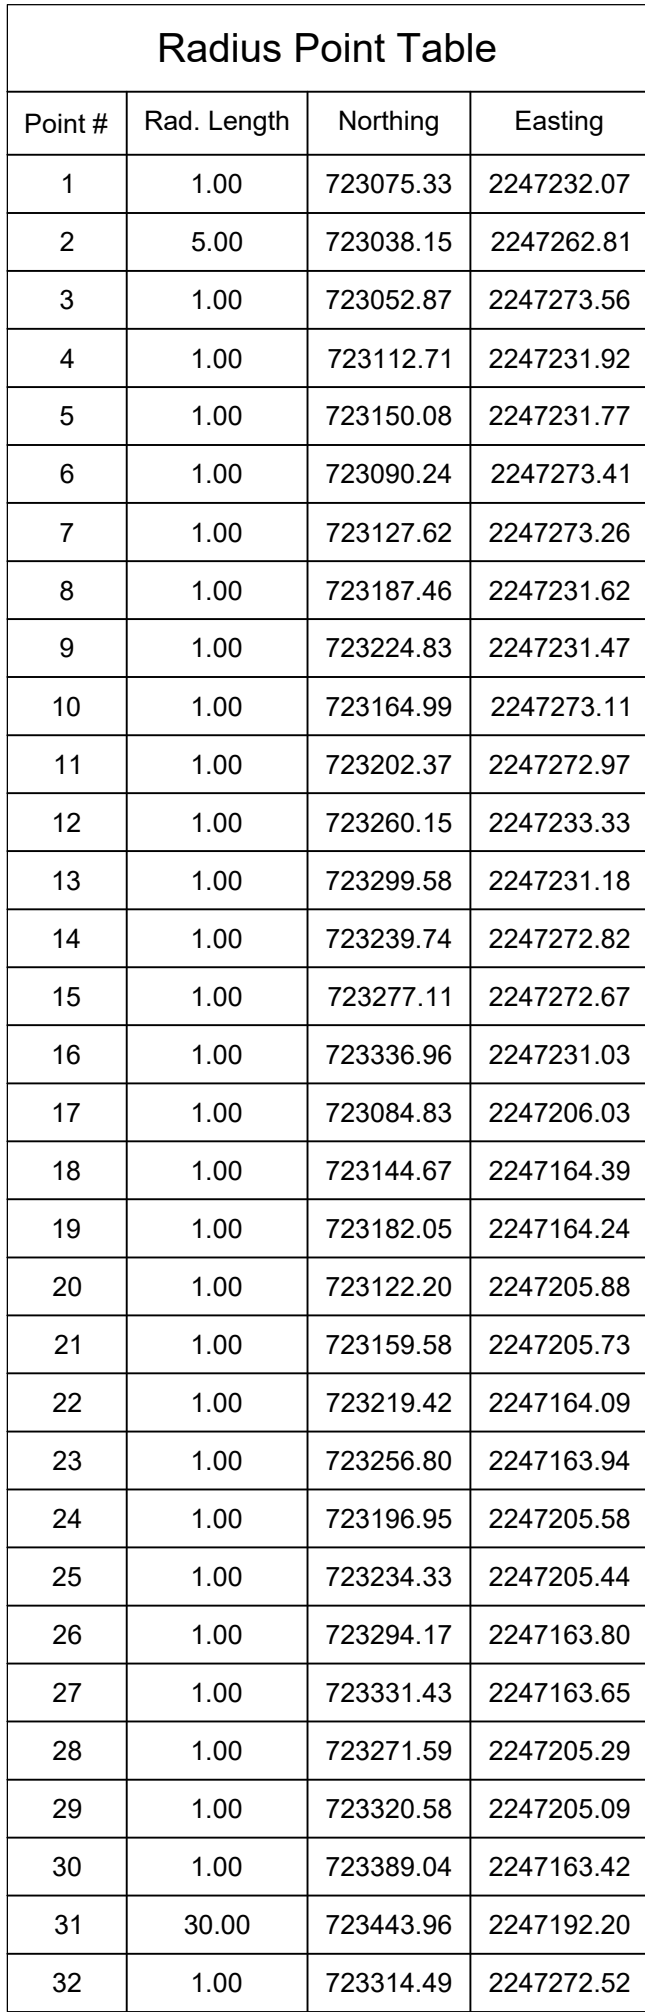
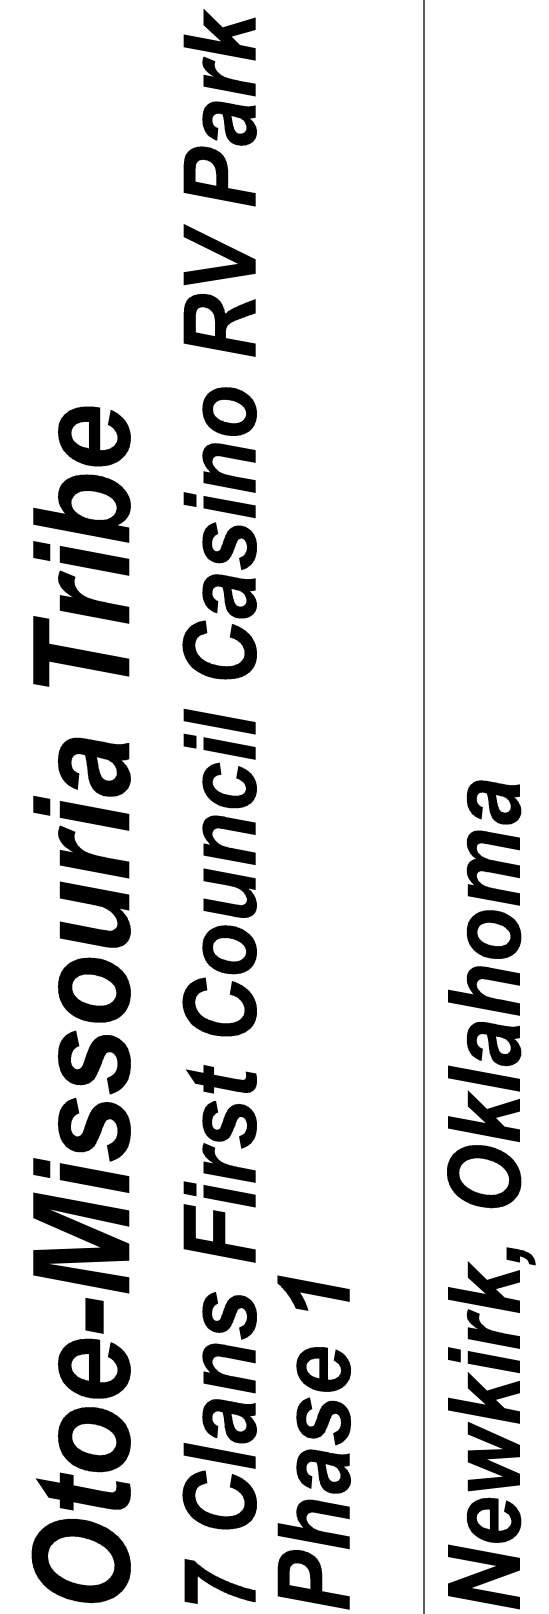


GENERAL NOTES

- A. REFER TO SHEET V-101 FOR BASIS OF VERTICAL AND HORIZONTAL CONTROL
- B. REFER TO SHEET C-001 FOR ADDITIONAL NOTES AND REQUIREMENTS
- C. DIMENSIONS SHOWN ARE TO FACE OF CURB/EDGE OF PAVEMENT UNLESS OTHERWISE NOTED
- D. CONTRACTOR SHALL EXERCISE CARE TO AVOID DAMAGE TO EXISTING PAVEMENT TO REMAIN. ANY DAMAGE TO EXISTING PAVEMENT TO REMAIN SHALL BE REPAIRED TO THE OWNER'S SATISFACTION AT THE CONTRACTOR'S EXPENSE.
- E. CONSTRUCTION FENCE SHALL BE PLACED AROUND ALL AREAS OF WORK WHEN WORK IS TAKING PLACE.
- F. THE CONTRACTOR SHALL PHASE AND COORDINATE THE WORK SO AS TO MINIMIZE THE DISRUPTION OF TRAFFIC AND PEDESTRIAN ACCESS TO ADJACENT FACILITIES.
- I. ALL CONSTRUCTION SHALL BE IN ACCORDANCE WITH ADA REQUIREMENTS FOR ACCESS.
- K. FOR CLARITY, UTILITIES ARE NOT SHOWN ON THIS PLAN. REFER TO SHEET CU101 FOR UTILITY LAYOUT PLAN.
- L. FOR CLARITY, JOINTING IS NOT SHOWN ON THIS PLAN. REFER TO 9-C/501 FOR JOINT LAYOUT PLAN.

CONTRACTOR MUST VERIFY LOCATION AND DEPTH OF ALL UTILITIES PRIOR TO ANY EXCAVATION ACTIVITIES. CONTRACTOR MUST VERIFY UTILITIES HAVE BEEN TAKEN OUT OF SERVICE BEFORE REMOVAL OR RELOCATION.

1. CONCRETE CURB. RE: 6/C-501.
2. CONCRETE CURB TERMINAL. RE: 7/C-501.
3. RV STALL SIGNAGE. RE: 9/C-503.
4. WAY FINDING SIGN #1. RE: 7/C-503.
5. NOT USED.
6. NOT USED.
7. HYPOPOWER POWERPORT. INCLUDE GREEN TOP AND CLEAR LIGHT. PROVIDE MINIMUM (1) ONE 3/4" HOSE BIB. 30A AND 50A ELECTRIC SERVICE AT ALL PEDESTALS. NO SUBSTITUTIONS.
8. LIGHT POLE. RE: ELECTRICAL.
9. BOLLARD. RE: 13/C-502.
10. DUMPSTER PAD. RE: 2/C-504.
11. NOT USED.
12. SEWER CONNECTION RE: 6/C-503.
13. BARBEQUE PIT BY OTHERS.
14. 10000 GALLON SEWER HOLDING TANK.
15. NOT USED.
16. CONCRETE SIDEWALK. SIM. TO RE: 5/C-501

[illegible]

PROJECT INFORMATION:	
DESIGNED BY:	BRS
DRAWN BY:	BRS
REVIEWED BY:	RFK
PROJECT MANAGER:	JET

PROJECT NUMBER:
2022-013-02
SHEET TITLE:
SITE PLAN

ISSUE DATE:
FEBRUARY 15, 2023
SHEET NUMBER:

CS101